


> 17' round Diffusers? *yes*  
 > 24\"/>

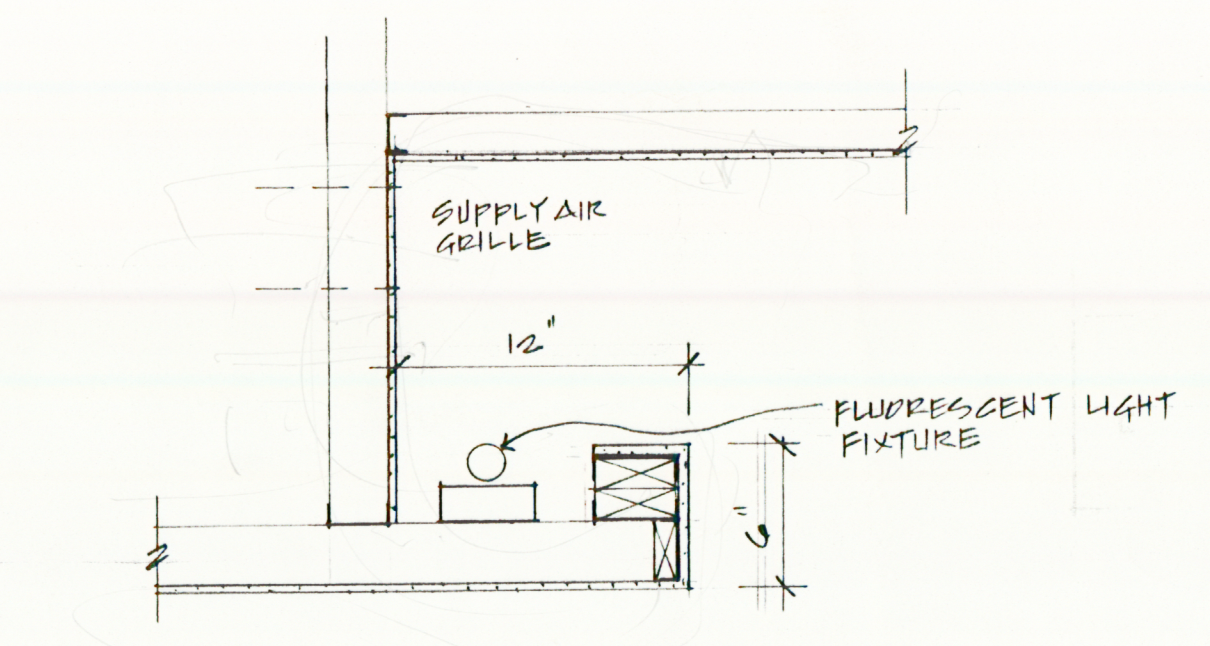

1 CEILING COVE DETAIL  
 5 1/2" = 1'-0"

- FLUORESCENT LIGHT FIXTURE
- POTLIGHT
- SUPPLY AIR DIFFUSER
- RETURN AIR GRILLE

*May 31/00 Structural only*

<p>COMMERCIAL BUILDING RENOVATION</p> <p>380 ALDER ST.        CAMPBELL RIVER BC</p>
<p>OFFICE REFLECTED CEILING PLAN</p>
<p>ARRIZAN        DESIGN + DRAFTING        COURTENAY BC 338-9823</p>
<p>DATE: MAY /00        SCALE: 1/4" = 1'-0"        DRAWN BY: K. KAPTEIN</p>
<p>DWG 5 OF 9</p>